


ST-4696

ST-4696


ST-4696

ST-4696

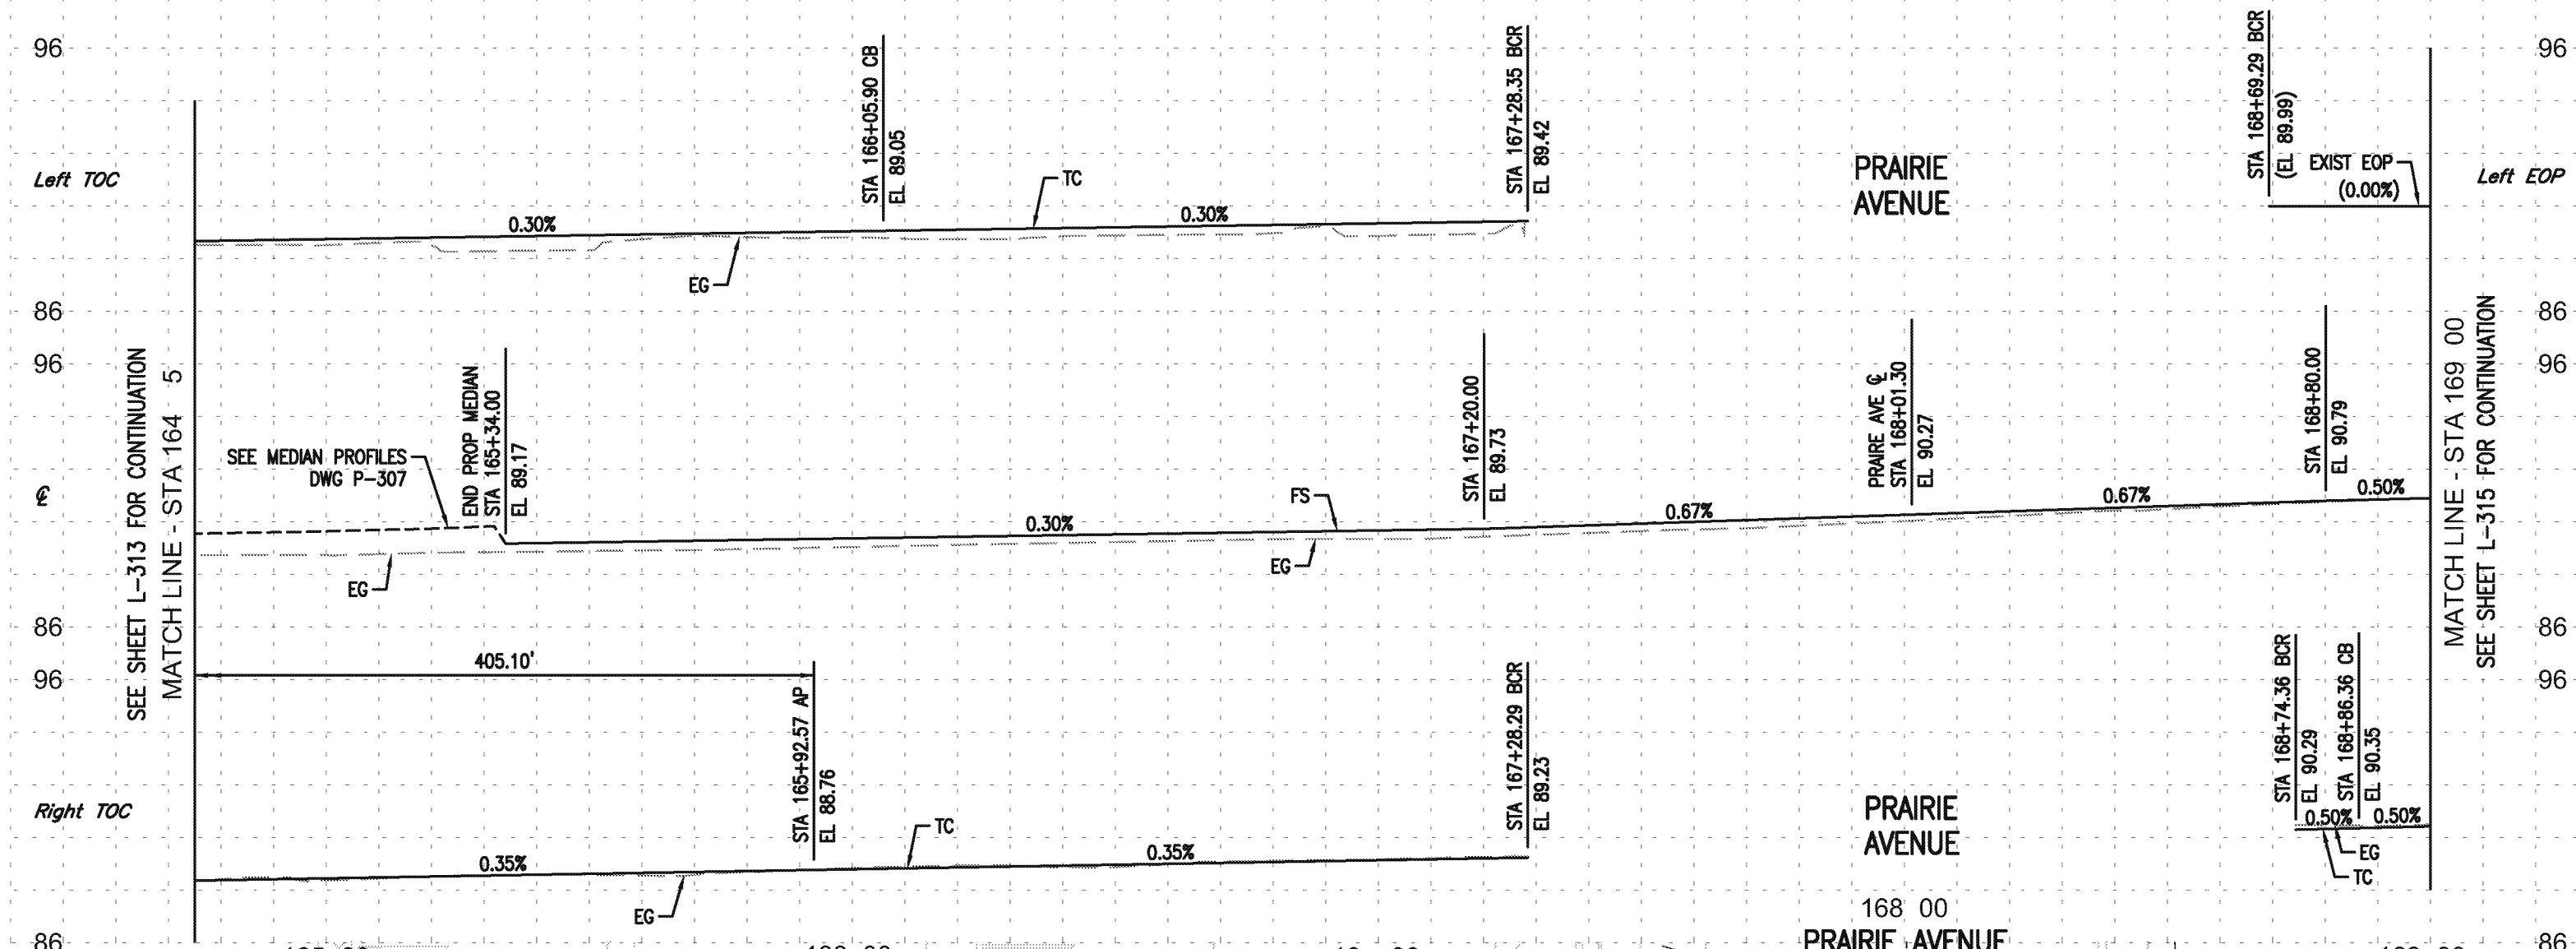

- NOTES:**
1. ALL CURB AND GUTTER ARE TYPE A2-6 UNLESS OTHERWISE NOTED.
  2. ALL MEDIAN CURB ARE TYPE A1-8 UNLESS OTHERWISE NOTED.
  3. ALL DRIVEWAYS ARE TYPE A AND X=3" UNLESS OTHERWISE NOTED.
  4. PROTECT IN PLACE ALL CURB DRAINS. REPLACE IF DAMAGED DURING CONSTRUCTION.
  5. SEE LANDSCAPE PLANS FOR TREE WELL AND PLANTER LOCATIONS.
  6. SEE STREET LIGHTING PLANS FOR STREET LIGHT LOCATIONS.
  7. SEE STORM DRAIN PLANS FOR CB AND LOCAL DEPRESSION LOCATIONS.
  8. SEE DWG P-304 FOR CURB RETURN AND CENTERLINE PROFILES.
  9. SEE DWG PI-309 FOR INTERSECTION DETAIL.
  10. SEE DWG C-310 FOR ADDITIONAL INFORMATION FOR INLET.

CURVE TABLE				
CURVE	R	Δ	L	T
A	35.00'	89°57'48"	54.96'	34.98'
B	35.00'	90°02'10"	54.98'	35.00'
C	35.00'	90°02'25"	55.00'	35.02'
D	194.08'	11°53'37"	40.29'	20.22'
E	2.00'	168°13'54"	5.87'	19.41'

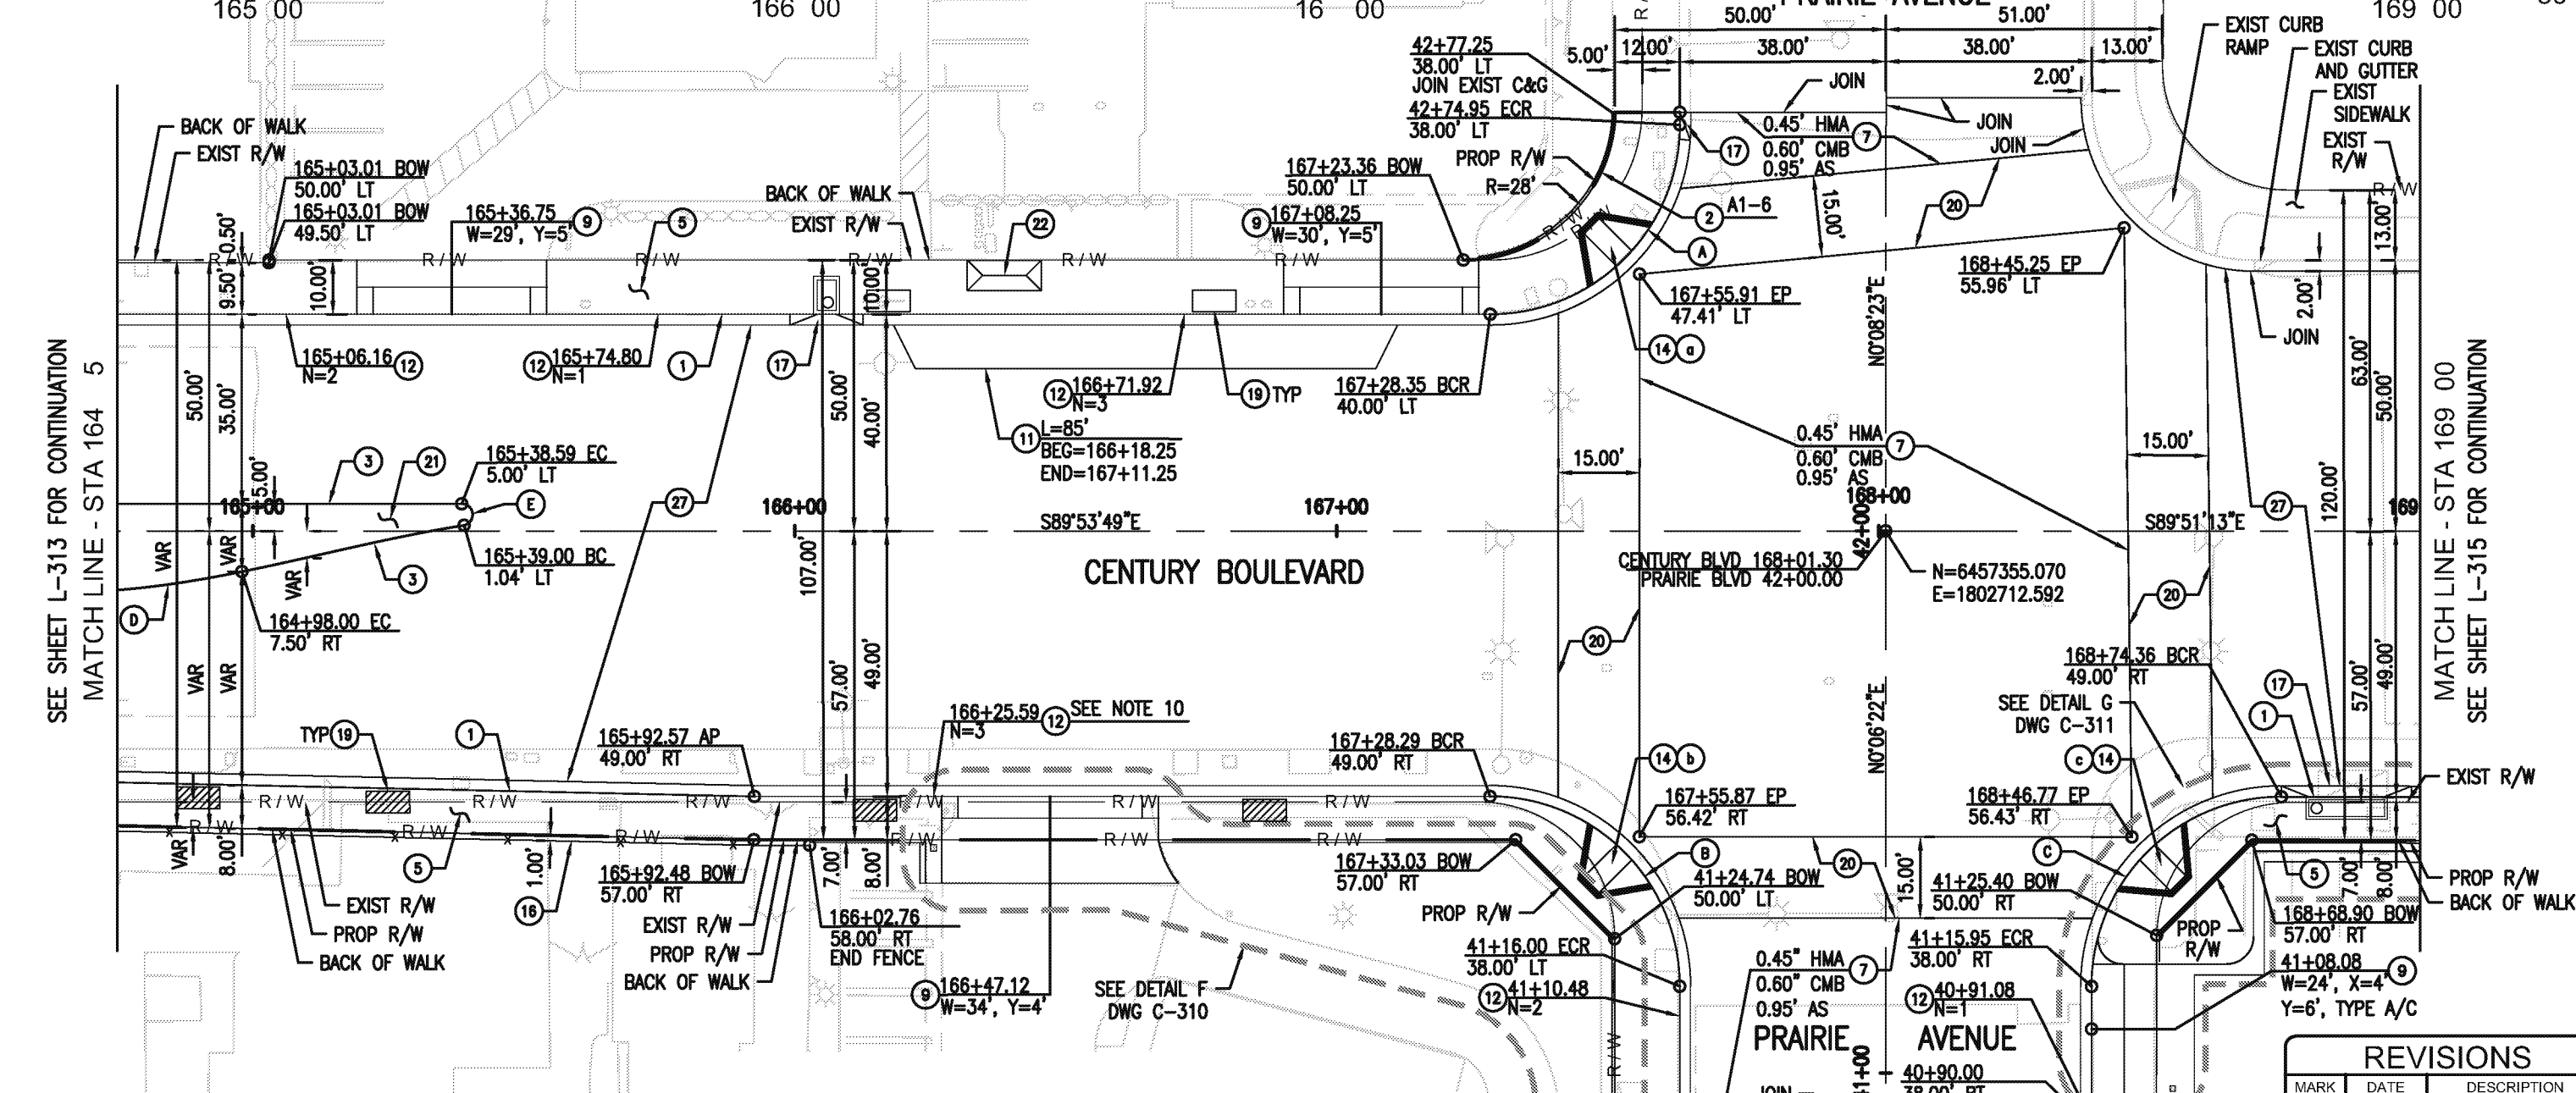

- CONSTRUCTION NOTES:**
- 1 PCC CURB AND GUTTER PER SPPWC STD PLAN 120-2 (PCC OVER 6" CMB)
  - 2 PCC CURB PER SPPWC STD PLAN 120-2 (PCC OVER 6" CMB)
  - 3 PCC MEDIAN CURB PER SPPWC STD PLAN 120-2 (PCC OVER 6" CMB)
  - 5 PCC SIDEWALK PER SPPWC STD PLAN 112-2 (4" PCC ON 4" CMB)
  - 7 HMA PAVEMENT ON BASE MATERIAL PER TYP SECTIONS
  - 9 PCC COMMERCIAL DRIVEWAY PER SPPWC STD PLAN 110-2 (PCC OVER 6" CMB)
  - 11 PCC BUS PAD PER SPPWC STD PLAN 131-2, T=9.6", B=12"
  - 12 CURB DRAIN PER SPPWC STD PLAN 150-3
  - 14 PCC CURB RAMP PER SPPWC STD PLAN 111-5, OR AS SHOWN (PCC OVER 4" CMB)
  - 16 CHAIN LINK FENCE AND DRIVE GATE PER SPPWC STD PLAN 600-3, H=6". FABRIC SHALL NOT BE USED.
  - 17 CONSTRUCT LOCAL DEPRESSION AT CATCH BASIN PER STORM DRAIN PLANS
  - 19 TREE WELL PER LANDSCAPING PLAN
  - 20 COLORED CONCRETE CROSSWALK WITH CONCRETE BANDING PER DETAIL ON SHEET C-301
  - 21 PLANTING AREA PER LANDSCAPING PLAN
  - 22 BUS SHELTER, BUS STOP SIGN, AND TRASH RECEPTACLE PER DETAIL ON SHEET C-301
  - 27 PAVEMENT PER TYP SECTIONS

CURB RAMP DATA						
STATION	OFFSET	CASE	TYPE	Y	Z	ANGLE
a 167+53.09	50.24' LT	A	1	5.5'	8.5'	-
b 167+53.04	59.25' RT	A	1	5.5'	8.5'	-
c 168+49.60	59.26' RT	A	1	6'	8'	-

REVISIONS		
MARK	DATE	DESCRIPTION

**AECOM**

300 S. GRAND AVE.  
LOS ANGELES, CA 90071  
T 213.983.8100 F 213.983.8178  
www.aecom.com

REGISTERED PROFESSIONAL ENGINEER  
STATE OF CALIFORNIA  
C 45779  
EX. 12/31/18  
CIVIL

**CITY OF INGLEWOOD, CALIFORNIA  
PUBLIC WORKS DEPARTMENT**

PROJECT TITLE:  
**PLANS FOR IMPROVEMENT OF  
CENTURY BOULEVARD  
INGLEWOOD AVE TO DOTY AVE  
PLAN AND PROFILE-164+75 TO 169+00**

 
DESIGNED BY: \_\_\_\_\_  
DRAWN BY: \_\_\_\_\_  
CHECKED BY: \_\_\_\_\_

SUBMITTED BY / APPROVED BY:  
  
ELOY M. CASTILLO, RCE 69100 / PRINCIPAL CIVIL ENGINEER

DATE: **3/1/2018**

PLAN SCALE: \_\_\_\_\_  
PROFILE SCALE: VERTICAL \_\_\_\_\_  
HORIZONTAL \_\_\_\_\_


PLAN NO.: **L-314**  
SHEET NO.: **34 OF 203**



Drawing Name: R:\Projects\164+75\1649600\_Century\_Improvement\DWG\Sheet\164+75 to 169+00\_Century\_Improvement\164+75 to 169+00\_Century\_Improvement.dwg  
Last Operator: February 16, 2018 - 4:41PM by: tammarc

ST-4696

ST-4696

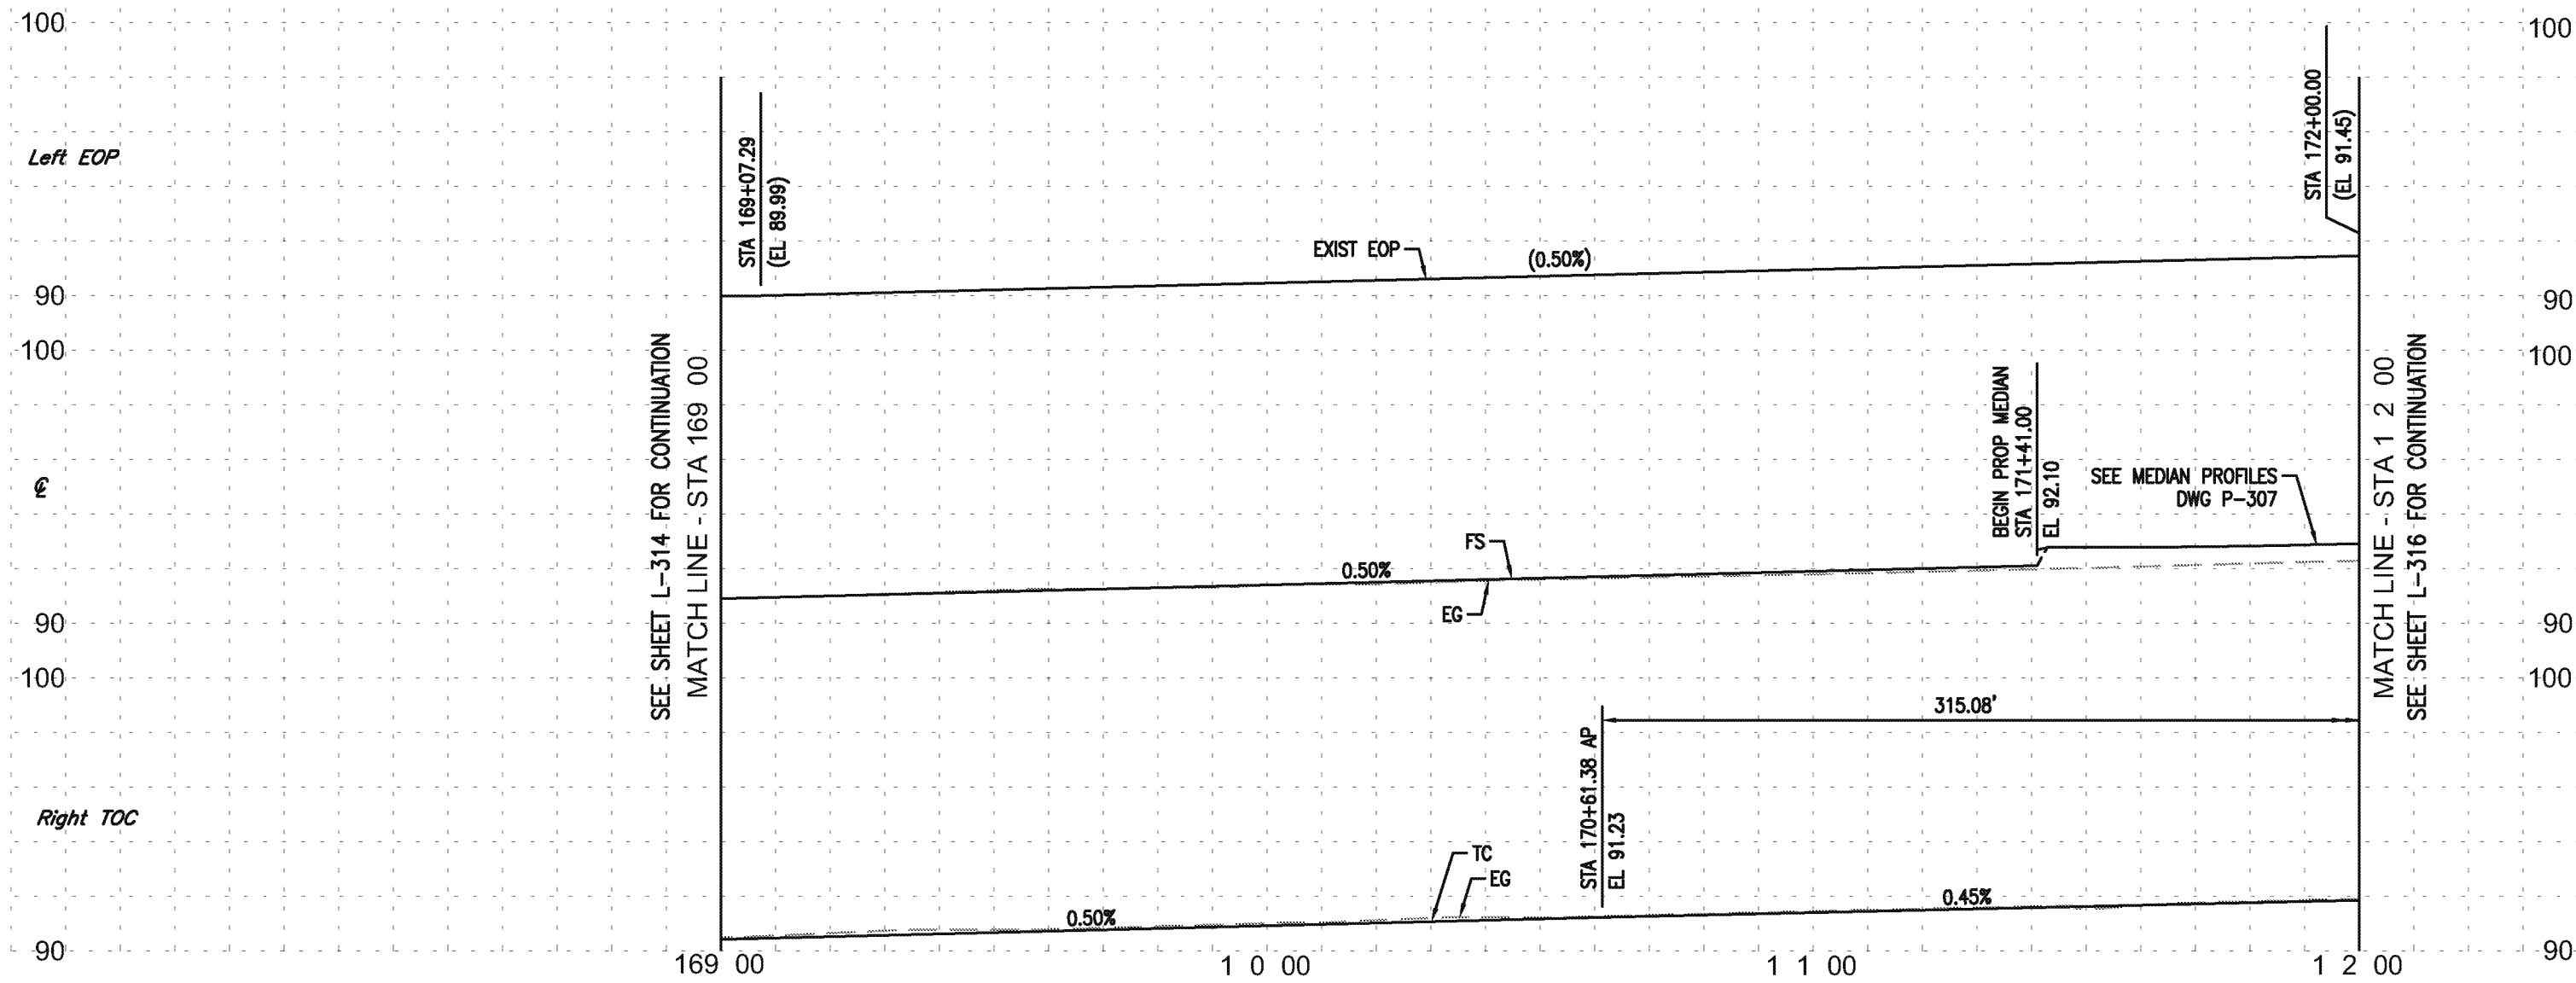


SEE SHEET L-314 FOR CONTINUATION  
MATCH LINE - STA 169 00

MATCH LINE - STA 1 2 00  
SEE SHEET L-316 FOR CONTINUATION

- NOTES:**
1. ALL CURB AND GUTTER ARE TYPE A2-6 UNLESS OTHERWISE NOTED.
  2. ALL MEDIAN CURB ARE TYPE A1-8 UNLESS OTHERWISE NOTED.
  3. ALL DRIVEWAYS ARE TYPE A AND X=3' UNLESS OTHERWISE NOTED.
  4. PROTECT IN PLACE ALL CURB DRAINS. REPLACE IF DAMAGED DURING CONSTRUCTION.
  5. SEE LANDSCAPE PLANS FOR TREE WELL AND PLANTER LOCATIONS.
  6. SEE STREET LIGHTING PLANS FOR STREET LIGHT LOCATIONS.


CURVE TABLE				
CURVE	R	Δ	L	T
A	2.00'	167°14'17"	8.54'	17.88'
B	162.50'	14°15'00"	40.42'	20.31'

- CONSTRUCTION NOTES:**
- 1 PCC CURB AND GUTTER PER SPPWC STD PLAN 120-2 (PCC OVER 6" CMB)
  - 3 PCC MEDIAN CURB PER SPPWC STD PLAN 120-2 (PCC OVER 6" CMB)
  - 5 PCC SIDEWALK PER SPPWC STD PLAN 112-2 (4" PCC ON 4" CMB)
  - 9 PCC COMMERCIAL DRIVEWAY PER SPPWC STD PLAN 110-2 (PCC OVER 6" CMB)
  - 11 PCC BUS PAD PER SPPWC STD PLAN 131-2, T=9.6", B=12"
  - 16 CHAIN LINK FENCE AND DRIVE GATE PER SPPWC STD PLAN 600-3, H=6'. FABRIC SHALL NOT BE USED.
  - 18 TREE WELL PER LANDSCAPING PLAN
  - 21 PLANTING AREA PER LANDSCAPING PLAN
  - 22 BUS SHELTER, BUS STOP SIGN, AND TRASH RECEPTACLE PER DETAIL ON SHEET C-301
  - 27 PAVEMENT PER TYP SECTIONS

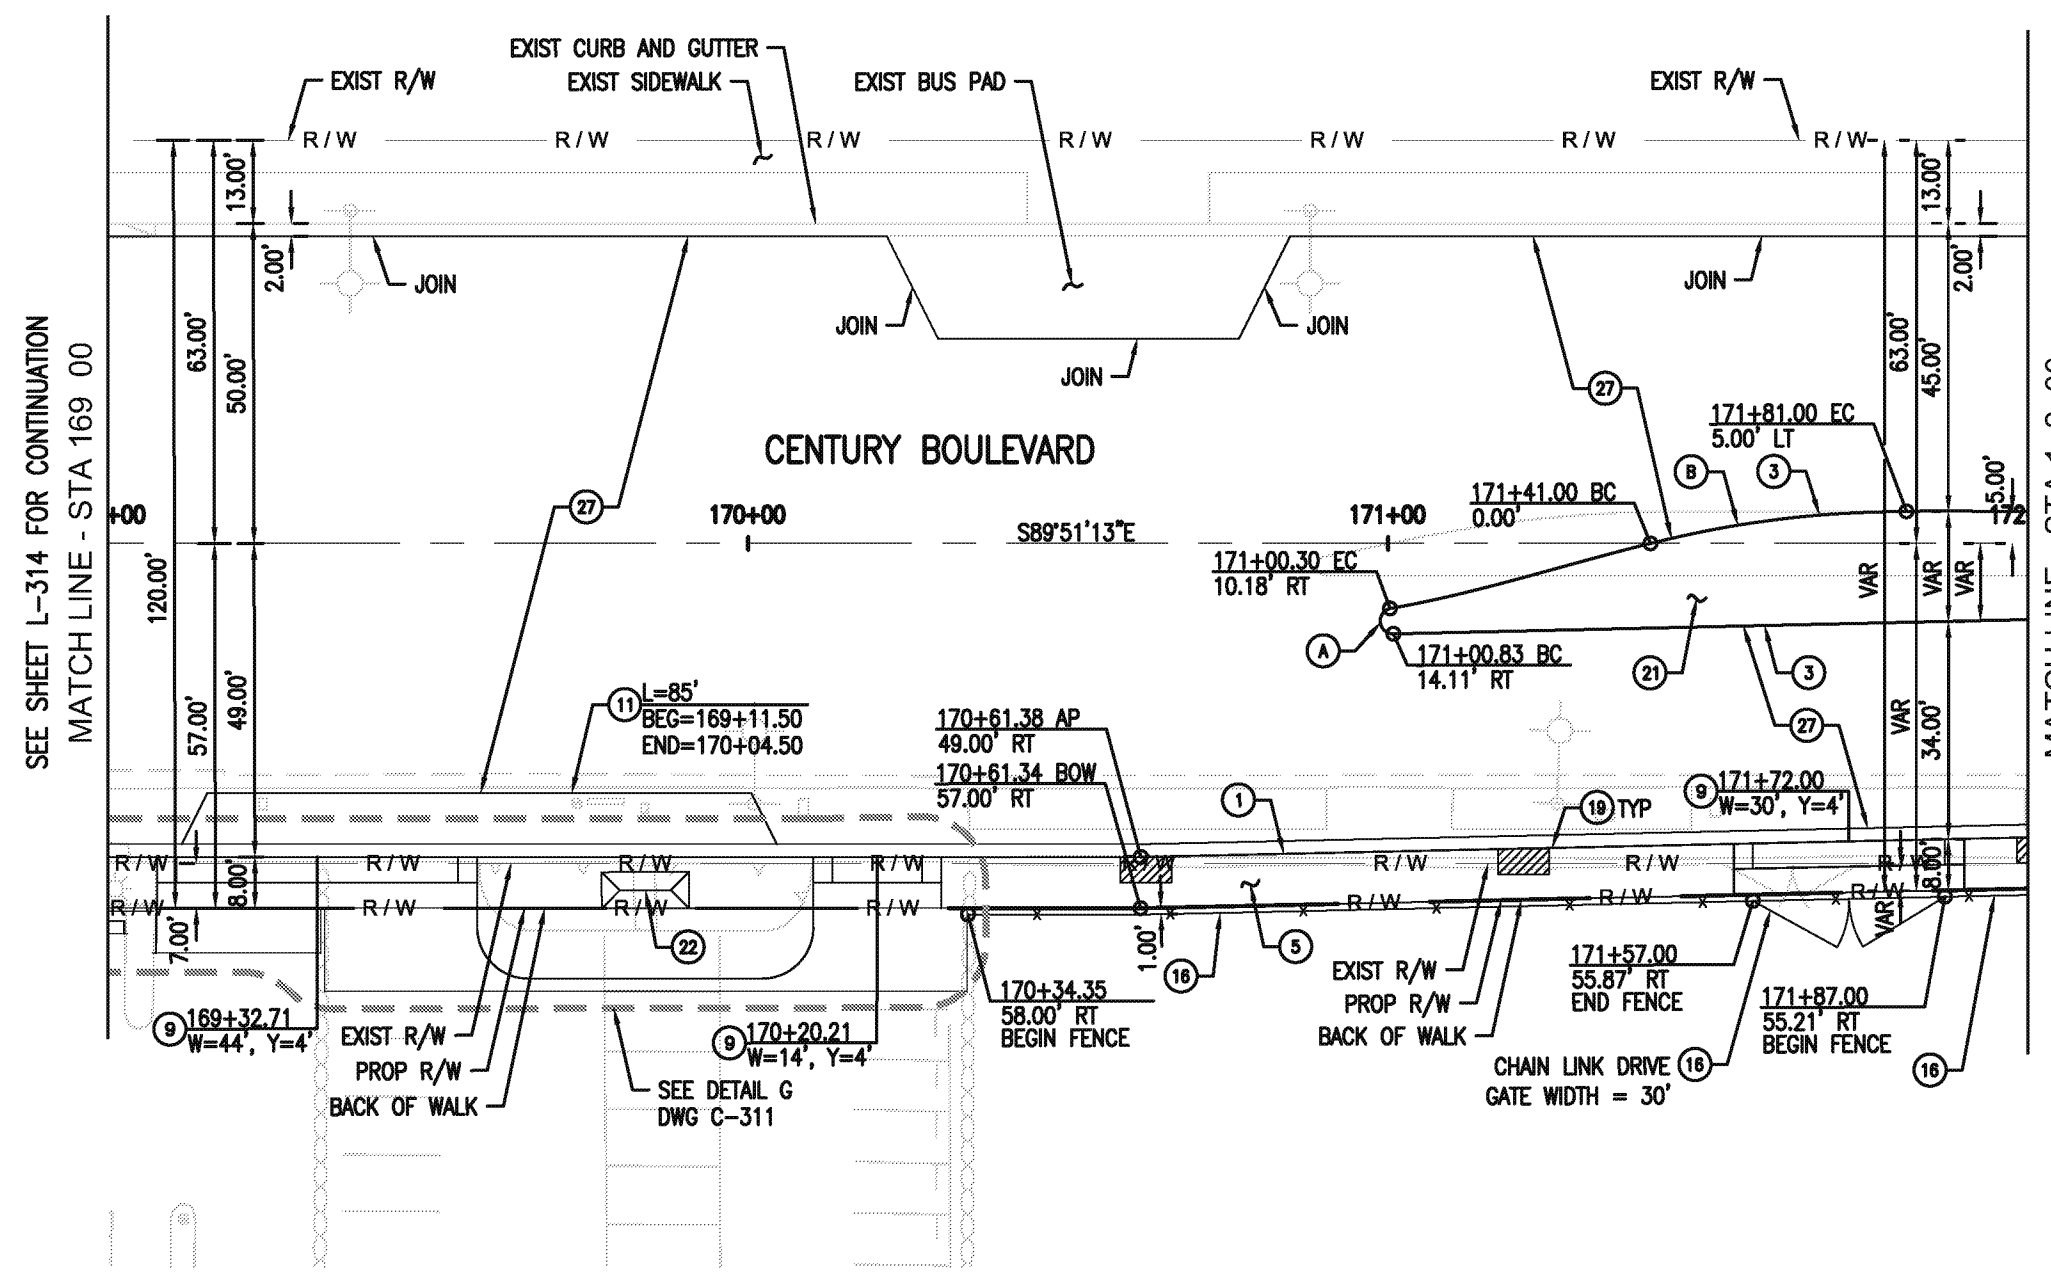

SEE SHEET L-314 FOR CONTINUATION  
MATCH LINE - STA 169 00

MATCH LINE - STA 1 2 00  
SEE SHEET L-316 FOR CONTINUATION

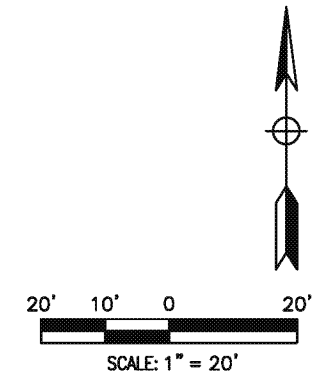

REVISIONS		
MARK	DATE	DESCRIPTION

**CITY OF INGLEWOOD, CALIFORNIA**  
**PUBLIC WORKS DEPARTMENT**

PROJECT TITLE:  
**PLANS FOR IMPROVEMENT OF  
CENTURY BOULEVARD  
INGLEWOOD AVE TO DOTY AVE  
PLAN AND PROFILE-169+00 TO 172+00**

DESIGNED BY: \_\_\_\_\_

DRAWN BY: \_\_\_\_\_

CHECKED BY: \_\_\_\_\_

SUBMITTED BY / APPROVED BY:

ELROY M. CASTILLO, RCE 69100 / PRINCIPAL CIVIL ENGINEER

PLAN NO.  
**L-315**

SHEET NO.  
35 OF 203

DATE  
**3/1/2018**

AECOM

AECOM  
300 S. GRAND AVE.  
LOS ANGELES, CA 90071  
T 213.983.8100 F 213.983.8178  
www.aecom.com

REGISTERED PROFESSIONAL ENGINEER  
STATE OF CALIFORNIA  
No. 54779  
Exp. 12/31/18  
CIVIL



ST-4696

ST-4696

Drawing Name: R:\Projects\1700\16900\16900\_CBRP\_Inglewood\CAD\Civil\Sheet\Project 3 - Inglewood\1700\16900\_Civil\Plan and Profile-169-315.dwg  
Last Operator: February 16, 2018 - 4:48PM by: jammern


ST-4696

ST-4696

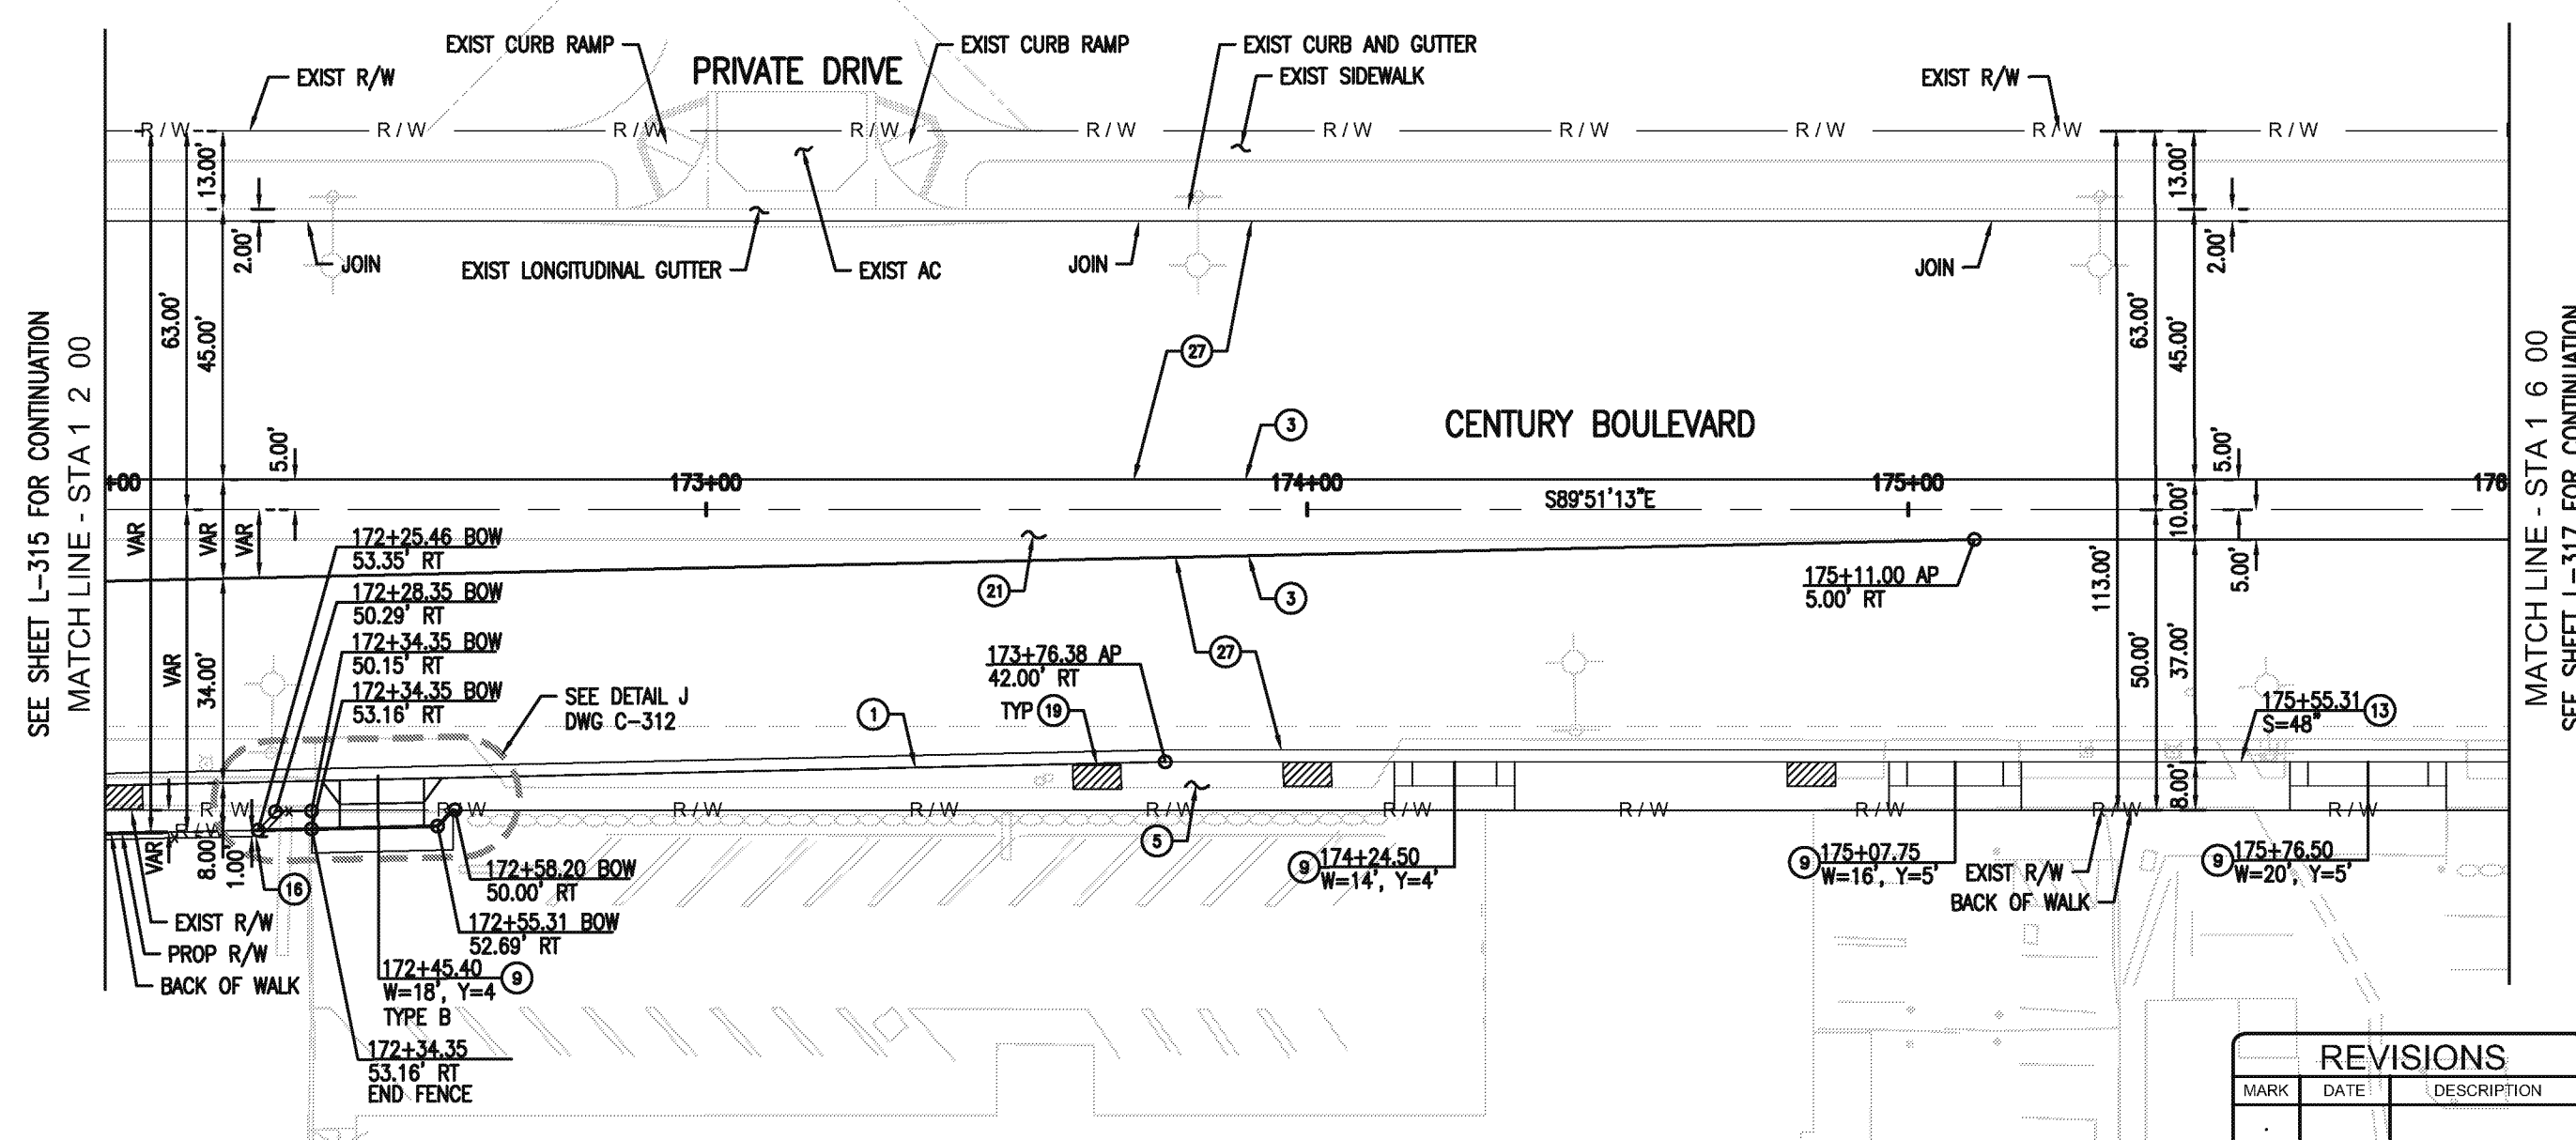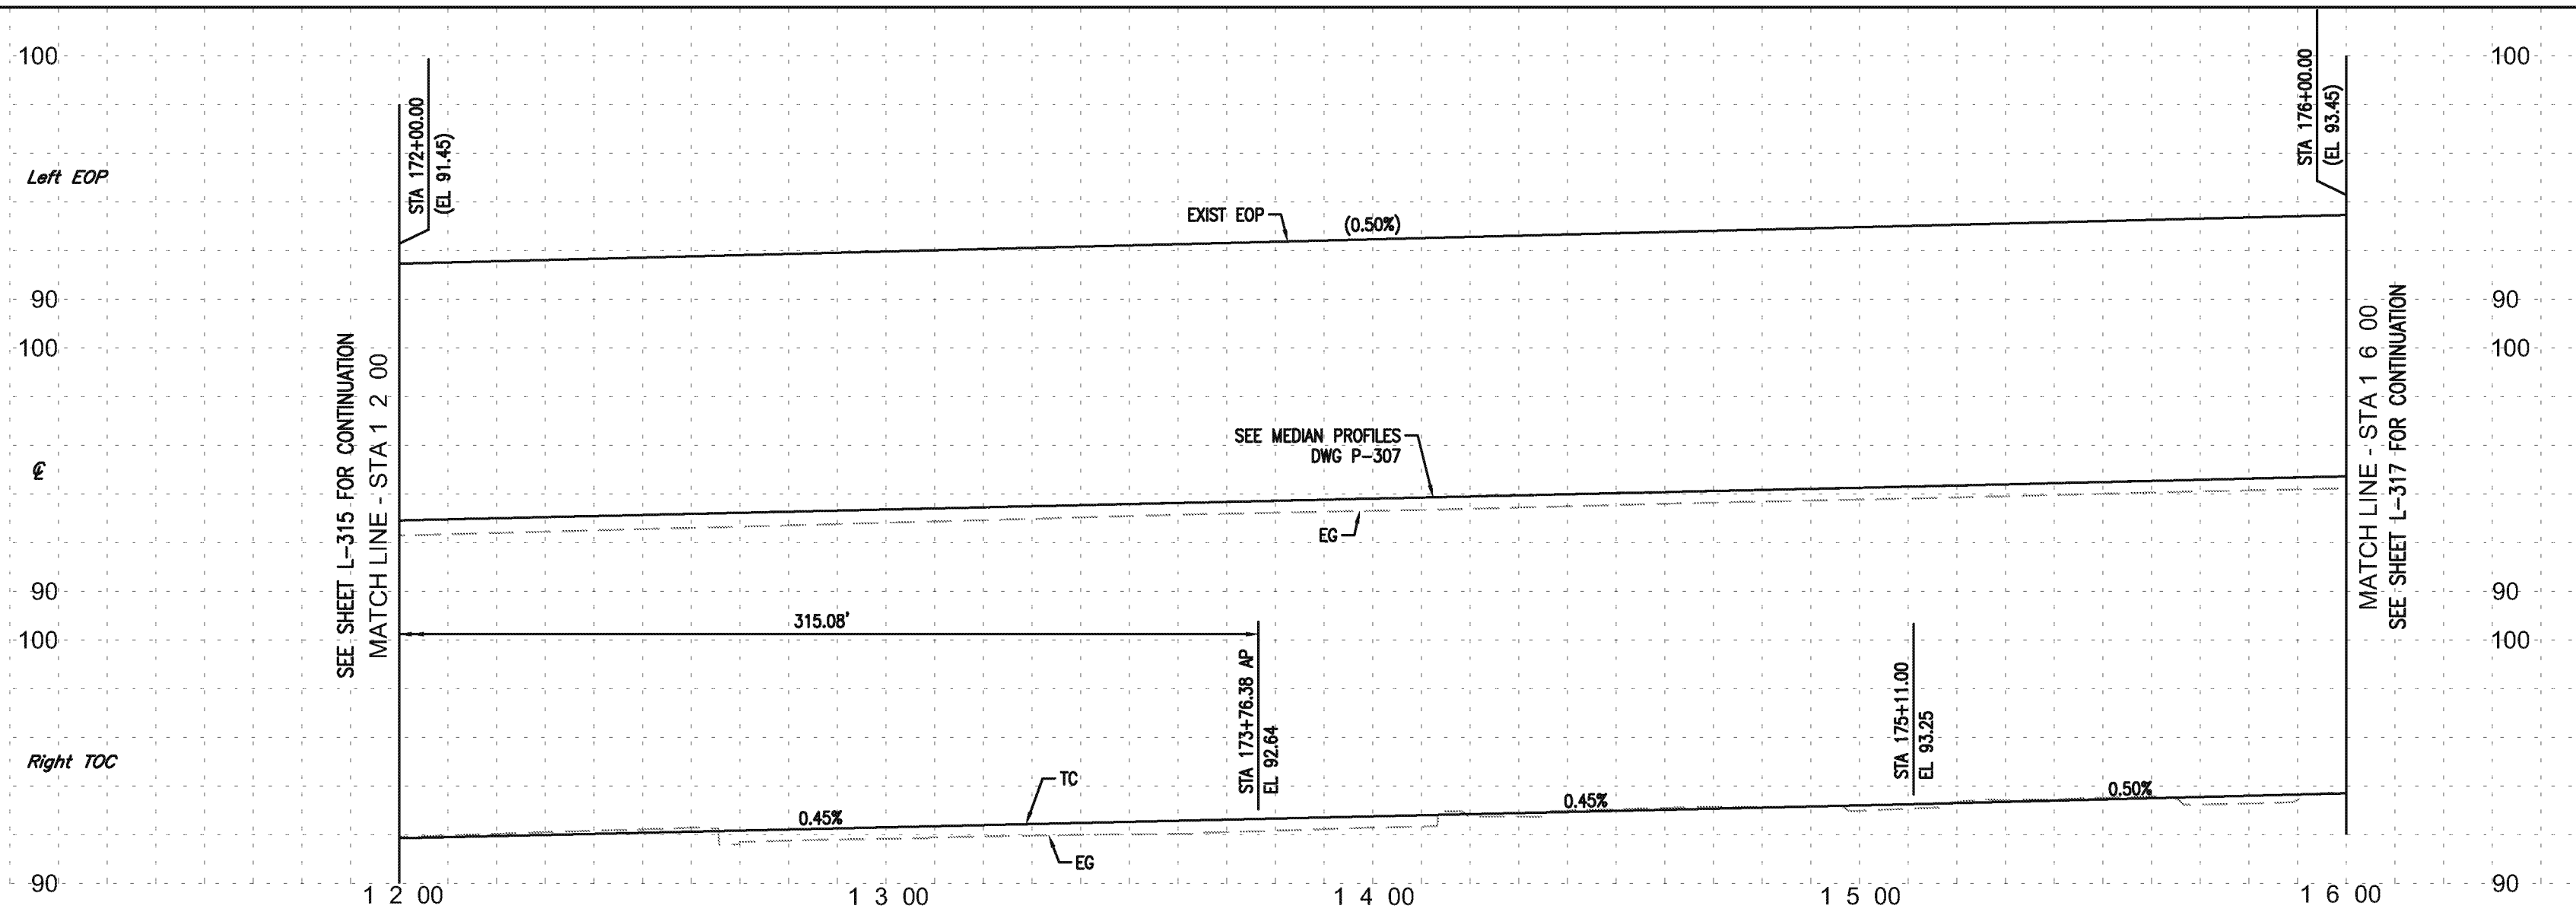

- NOTES:**
1. ALL CURB AND GUTTER ARE TYPE A2-6 UNLESS OTHERWISE NOTED.
  2. ALL MEDIAN CURB ARE TYPE A1-8 UNLESS OTHERWISE NOTED.
  3. ALL DRIVEWAYS ARE TYPE A AND X=3' UNLESS OTHERWISE NOTED.
  4. PROTECT IN PLACE ALL CURB DRAINS. REPLACE IF DAMAGED DURING CONSTRUCTION.
  5. SEE LANDSCAPE PLANS FOR TREE WELL AND PLANTER LOCATIONS.
  6. SEE STREET LIGHTING PLANS FOR STREET LIGHT LOCATIONS.

- CONSTRUCTION NOTES:**
- 1 PCC CURB AND GUTTER PER SPPWC STD PLAN 120-2 (PCC OVER 6" CMB)
  - 3 PCC MEDIAN CURB PER SPPWC STD PLAN 120-2 (PCC OVER 6" CMB)
  - 5 PCC SIDEWALK PER SPPWC STD PLAN 112-2 (4" PCC ON 4" CMB)
  - 9 PCC COMMERCIAL DRIVEWAY PER SPPWC STD PLAN 110-2 (PCC OVER 6" CMB)
  - 13 PARKWAY DRAIN PER SPPWC STD PLAN 151-2
  - 16 CHAIN LINK FENCE AND DRIVE GATE PER SPPWC STD PLAN 600-3, H=6'. FABRIC SHALL NOT BE USED.
  - 19 TREE WELL PER LANDSCAPING PLAN
  - 21 PLANTING AREA PER LANDSCAPING PLAN
  - 27 PAVEMENT PER TYP SECTIONS

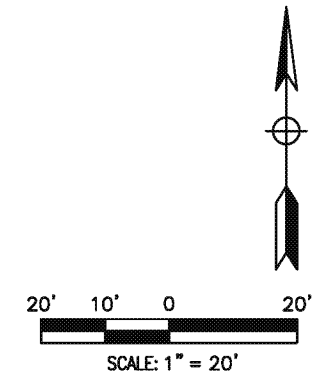

REVISIONS		
MARK	DATE	DESCRIPTION

**CITY OF INGLEWOOD, CALIFORNIA**  
**PUBLIC WORKS DEPARTMENT**

PROJECT TITLE:  
**PLANS FOR IMPROVEMENT OF  
CENTURY BOULEVARD  
INGLEWOOD AVE TO DOTY AVE  
PLAN AND PROFILE-172+00 TO 176+00**

PROFESSIONAL ENGINEER  
C 45779  
Exp. 12/31/18  
CIVIL  
STATE OF CALIFORNIA

DESIGNED BY: \_\_\_\_\_

DRAWN BY: \_\_\_\_\_

CHECKED BY: \_\_\_\_\_

SUBMITTED BY / APPROVED BY:  
  
ELOY M. CASTILLO, RCE 69100 / PRINCIPAL CIVIL ENGINEER

PLAN NO.  
**L-316**

SHEET NO.  
36 OF 203

DATE  
**3/1/2018**

AECOM

AECOM  
300 S. GRAND AVE.  
LOS ANGELES, CA 90071  
T 213.983.8100 F 213.983.8178  
www.aecom.com

REGISTERED PROFESSIONAL ENGINEER  
STATE OF CALIFORNIA  
C 45779  
Exp. 12/31/18  
CIVIL


ST-4696

ST-4696

Drawing Name: S:\Projects\172+00\172+00\_CBRP\_172+00\172+00\_CBRP\172+00\_CBRP\172+00\_CBRP.dwg  
Last Operator: February 16, 2018 - 4:44PM by: tammarc

ST-4696


ST-4696

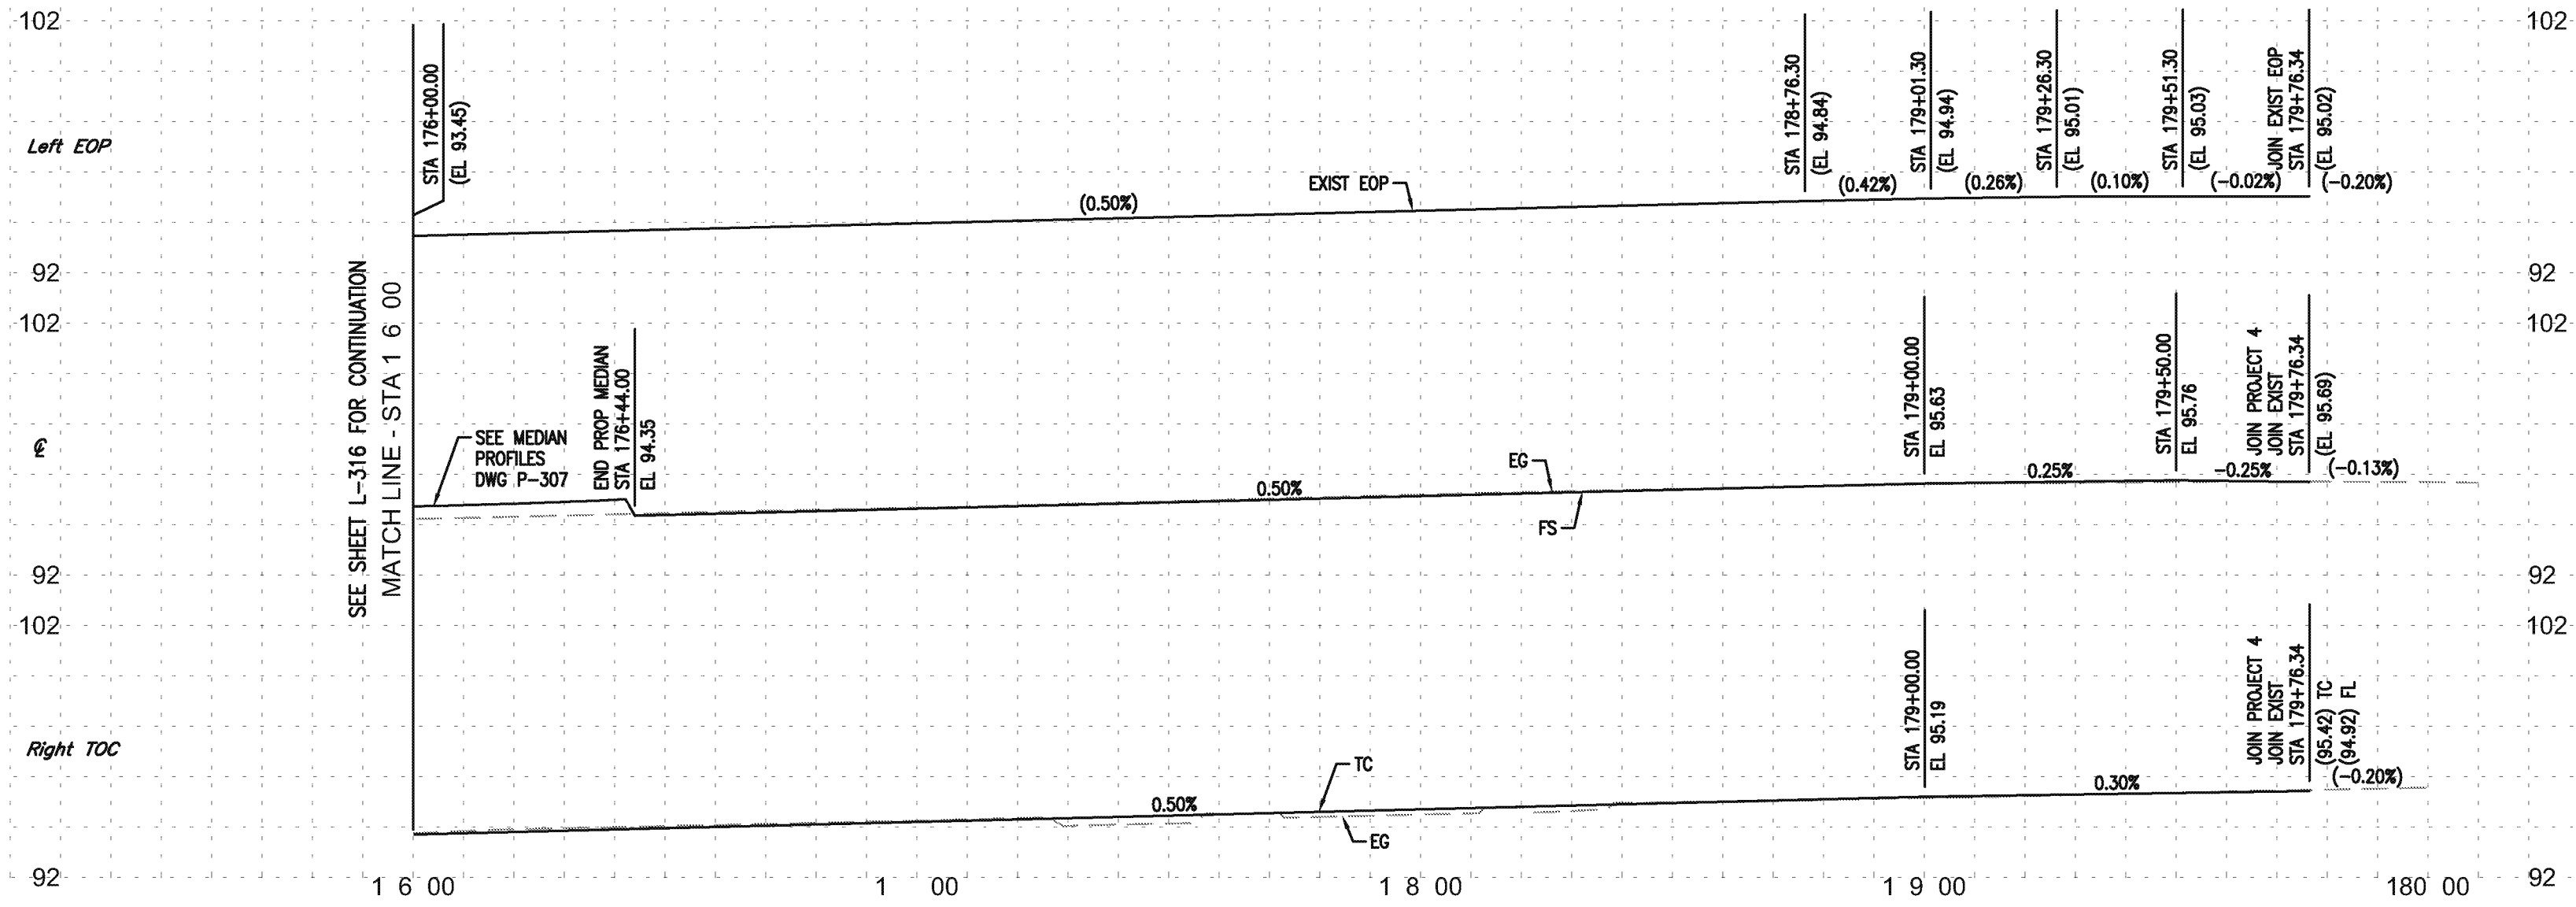

- NOTES:**
1. ALL CURB AND GUTTER ARE TYPE A2-6 UNLESS OTHERWISE NOTED.
  2. ALL MEDIAN CURB ARE TYPE A1-8 UNLESS OTHERWISE NOTED.
  3. ALL DRIVEWAYS ARE TYPE A AND X=3" UNLESS OTHERWISE NOTED.
  4. PROTECT IN PLACE ALL CURB DRAINS. REPLACE IF DAMAGED DURING CONSTRUCTION.
  5. SEE LANDSCAPE PLANS FOR TREE WELL AND PLANTER LOCATIONS.
  6. SEE STREET LIGHTING PLANS FOR STREET LIGHT LOCATIONS.

CURVE TABLE				
CURVE	R	Δ	L	T
A	81.25'	14°15'00"	20.21'	10.16'
B	2.00'	165°57'50"	5.79'	16.25'

- CONSTRUCTION NOTES:**
- 1 PCC CURB AND GUTTER PER SPPWC STD PLAN 120-2 (PCC OVER 6" CMB)
  - 3 PCC MEDIAN CURB PER SPPWC STD PLAN 120-2 (PCC OVER 6" CMB)
  - 5 PCC SIDEWALK PER SPPWC STD PLAN 112-2 (4" PCC ON 4" CMB)
  - 9 PCC COMMERCIAL DRIVEWAY PER SPPWC STD PLAN 110-2 (PCC OVER 6" CMB)
  - 11 PCC BUS PAD PER SPPWC STD PLAN 131-2, T=9.6", B=12"
  - 13 PARKWAY DRAIN PER SPPWC STD PLAN 151-2
  - 19 TREE WELL PER LANDSCAPING PLAN
  - 21 PLANTING AREA PER LANDSCAPING PLAN
  - 27 PAVEMENT PER TYP SECTIONS

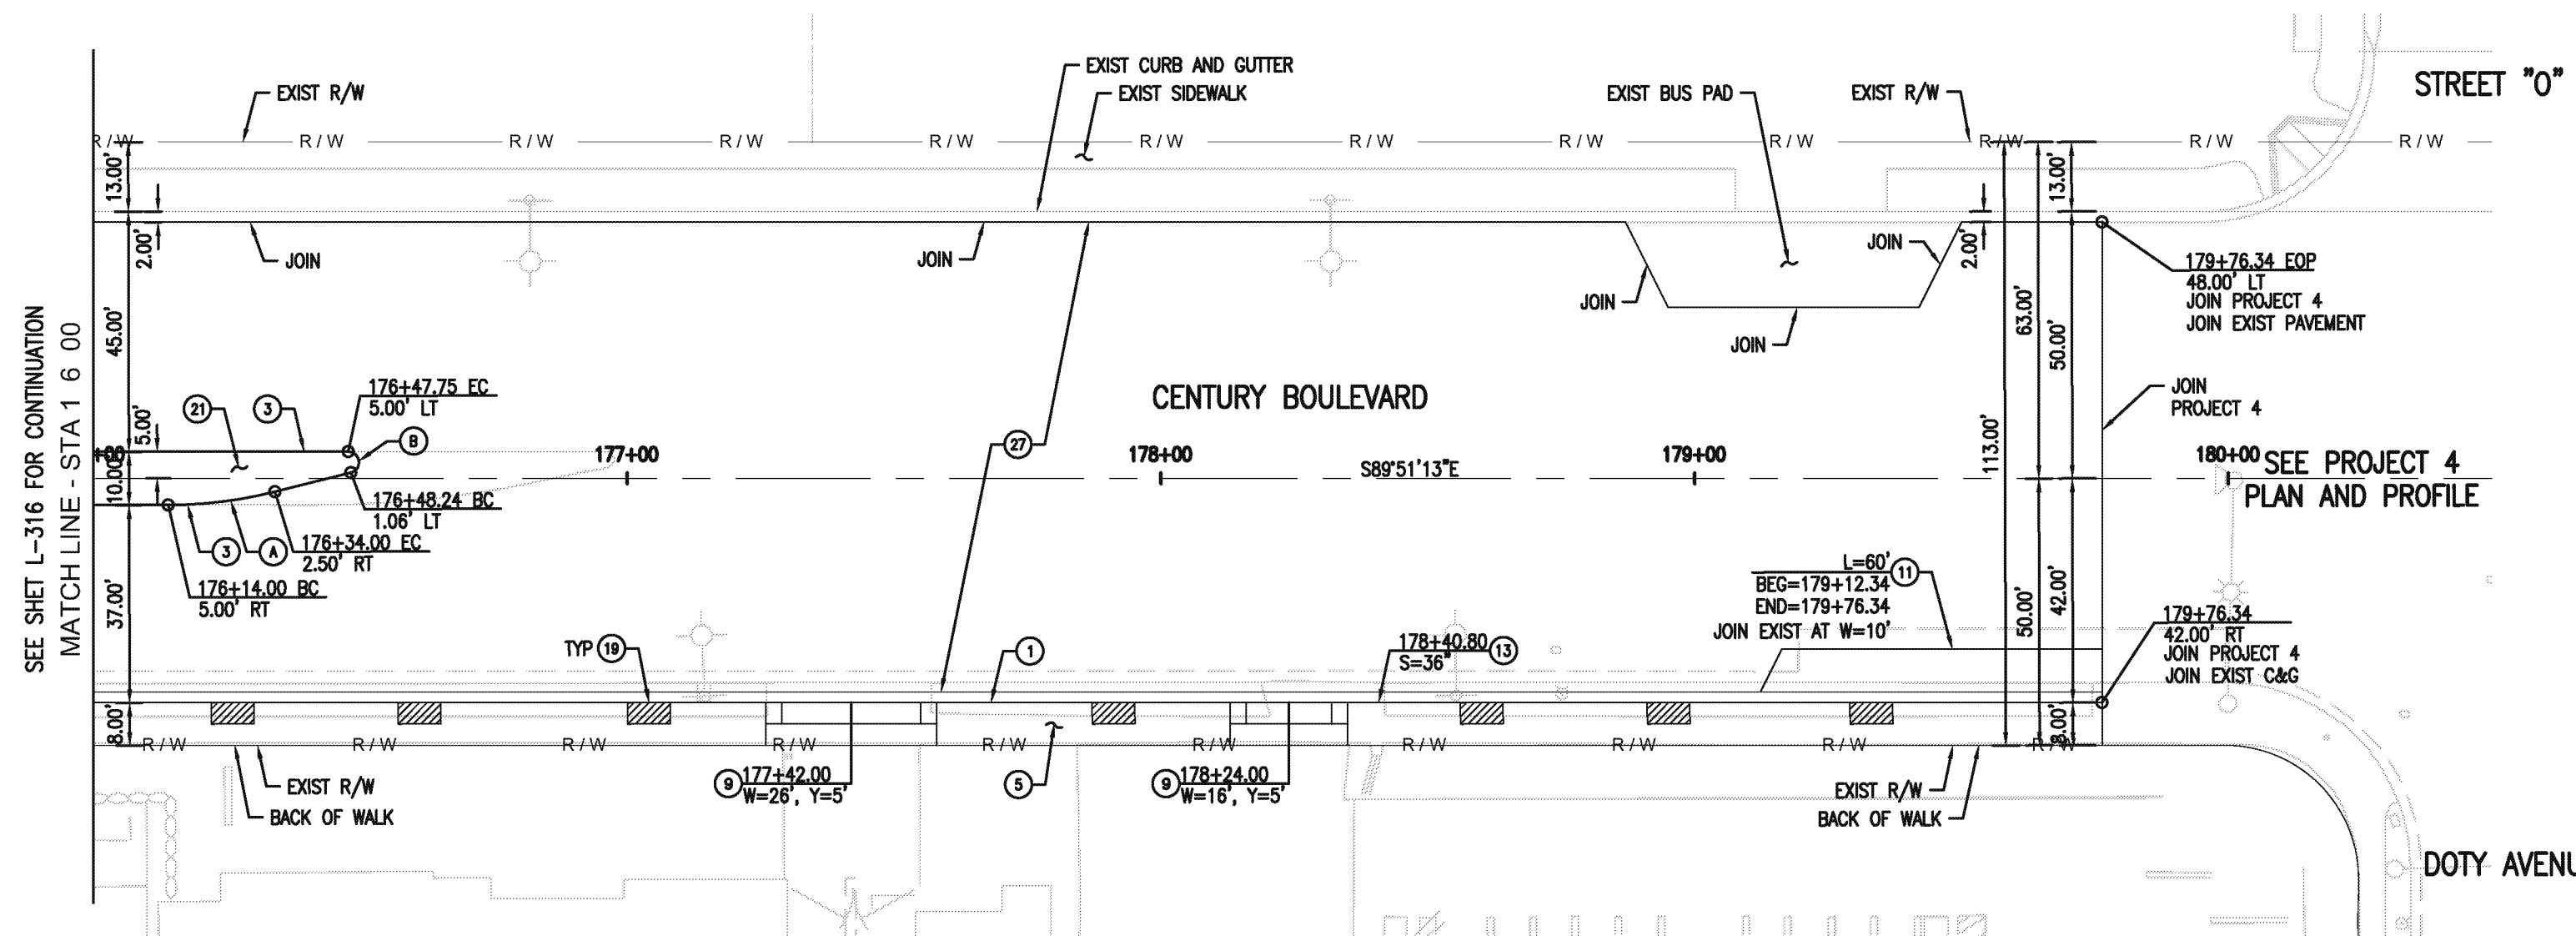

REVISIONS		
MARK	DATE	DESCRIPTION

**CITY OF INGLEWOOD, CALIFORNIA**  
PUBLIC WORKS DEPARTMENT

PROJECT TITLE:  
**PLANS FOR IMPROVEMENT OF CENTURY BOULEVARD INGLEWOOD AVE TO DOTY AVE**  
PLAN AND PROFILE-176+00 TO 179+65

DESIGNED BY: \_\_\_\_\_  
DRAWN BY: \_\_\_\_\_  
CHECKED BY: \_\_\_\_\_

SUBMITTED BY / APPROVED BY: \_\_\_\_\_  
DATE: **3/1/2018**

PLAN NO. L-31  
SHEET NO. 37 OF 203

**AECOM**

AECOM  
300 S. GRAND AVE.  
LOS ANGELES, CA 90071  
T 213.983.8100 F 213.983.8178  
www.aecom.com

REGISTERED PROFESSIONAL ENGINEER  
STATE OF CALIFORNIA  
C 45779  
12/31/18  
CIVIL

ST-4696

ST-4696